


BILL OF MATERIALS

DESCRIPTION	SIZE	QUANTITY	DM.	MFG.	CAT.#
SBC	#2 AWG	AS REQ.	FEET	-	-
PRECAST WELL	9 1/4"	1	EACH	ASSOCIATED PLASTICS 1010	-
GROUNDING ROD	3/4" X 10'	1	EACH	HOMAS & BETTS 7510	-
GROUND CLAMP	1/2" X 1"	1	EACH	ANDERSON GC-103-03	-

GROUNDING RING TEST WELL DETAIL

1


SCALE: NOT TO SCALE

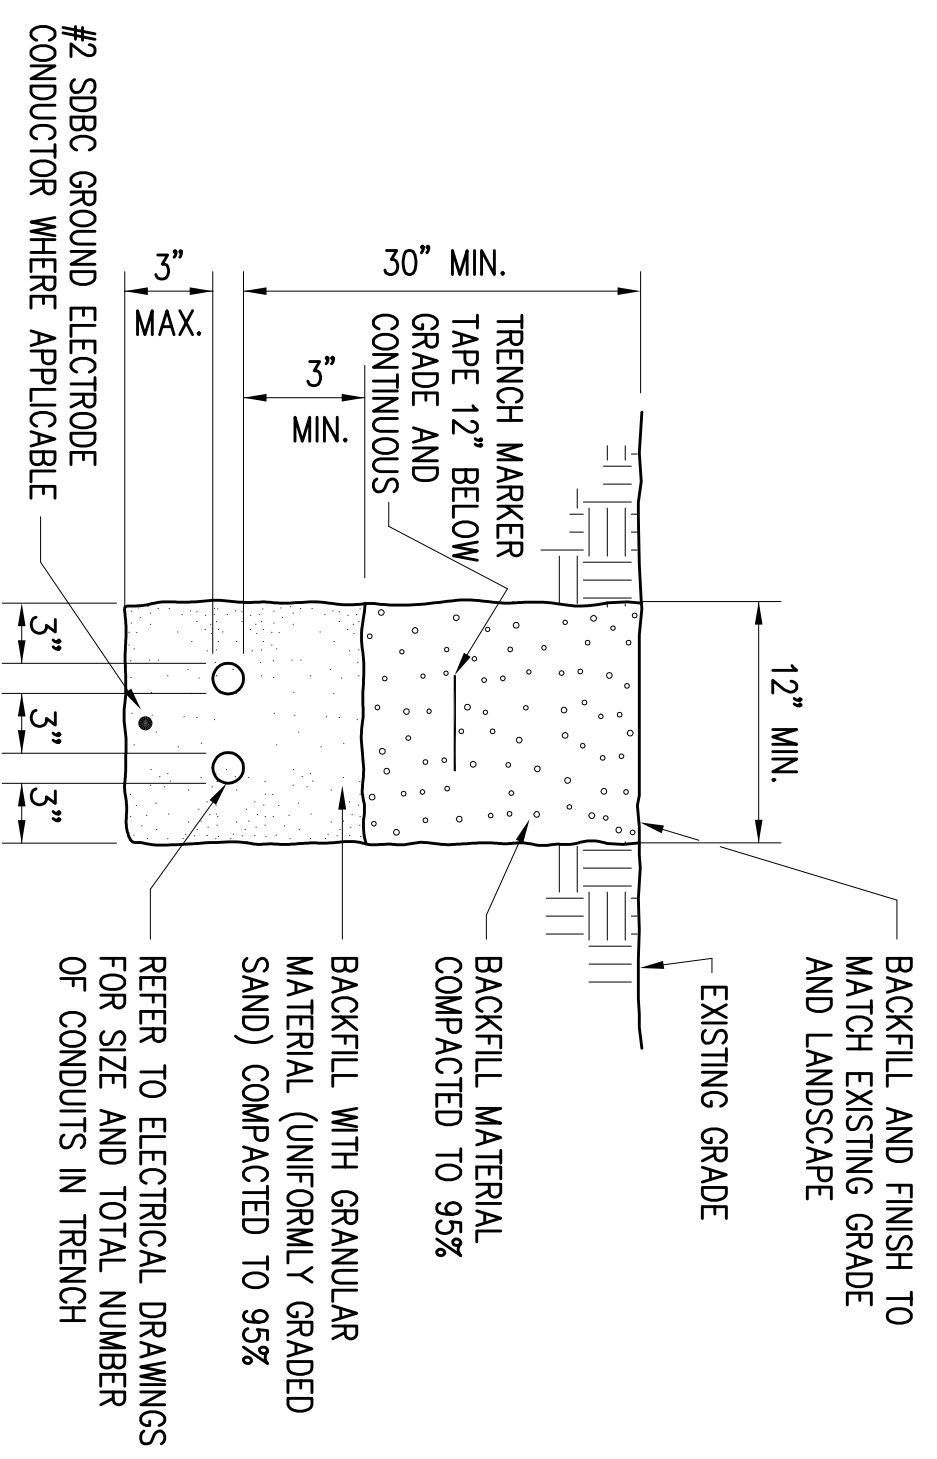

TRENCH DETAIL

2


SCALE: NOT TO SCALE

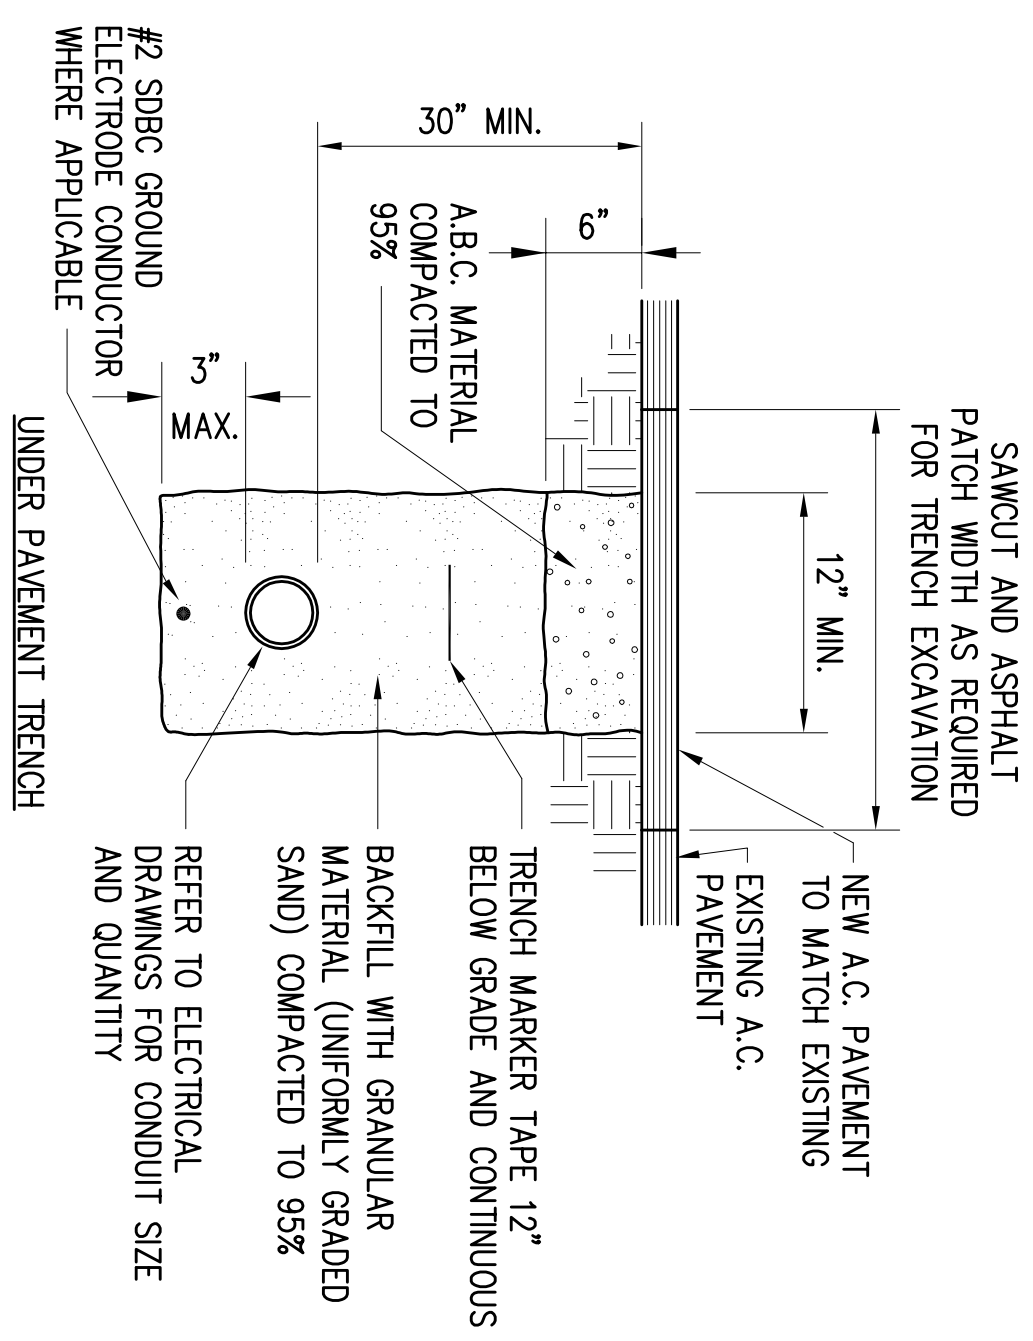

TRENCH DETAIL

3

SCALE: NOT TO SCALE

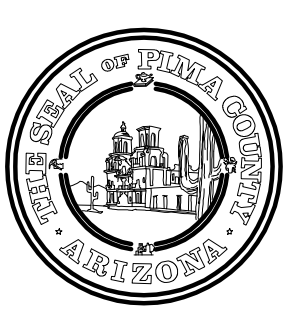

RICHEY BLVD. FUEL TANK REPLACEMENT

PIMA COUNTY
FACILITIES MANAGEMENT
150 WEST CONGRESS, 5TH FL.
TUCSON, AZ 85701



ARCHITECTURE
ENGINEERING
CONSTRUCTION MANAGEMENT

2051 W. SUNSET RD.
SUITE NO. 101
TUCSON, ARIZONA 85704

TEL: (520) 293-1488
FAX: (520) 293-6349
WWW.M3PENG.COM

Revisions

Description	Date

Drawn: RLA
Checked: -
Issue Date: 12-17-2010

Drawing Title
ELECTRICAL DETAILS

Sheet Number
EP502

M3PN 100100

Last Update: 7.1.2011