



RICHEY BLVD. FUEL TANK REPLACEMENT
PIMA COUNTY
 FACILITIES MANAGEMENT
 150 WEST CONGRESS, 5TH FL.
 TUCSON, AZ 85701

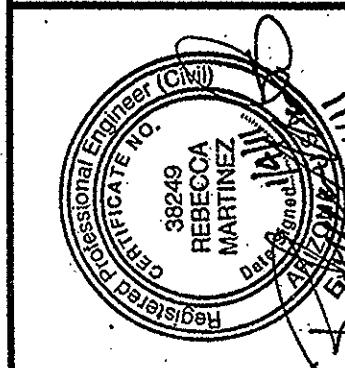

2051 W. SUNSET RD.
 SUITE NO. 101
 TUCSON, ARIZONA 85704
 TEL: (602) 993-4488
 FAX: (602) 993-4349
 WWW.M3PM.COM

ARCHITECTURE
 ENGINEERING
 CONSTRUCTION MANAGEMENT

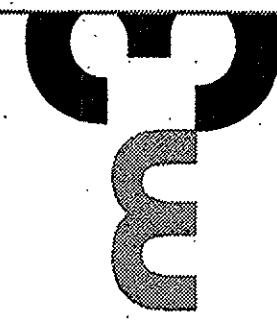

Revisions

Description	Date

Drawn: DEJ
 Checked: WB
 Issue Date: 12-17-2010


Drawing Title
CIVIL SITE GRADING PLAN

Sheet Number

C1102

M3PN 100100

Last Update: 1.4.2011

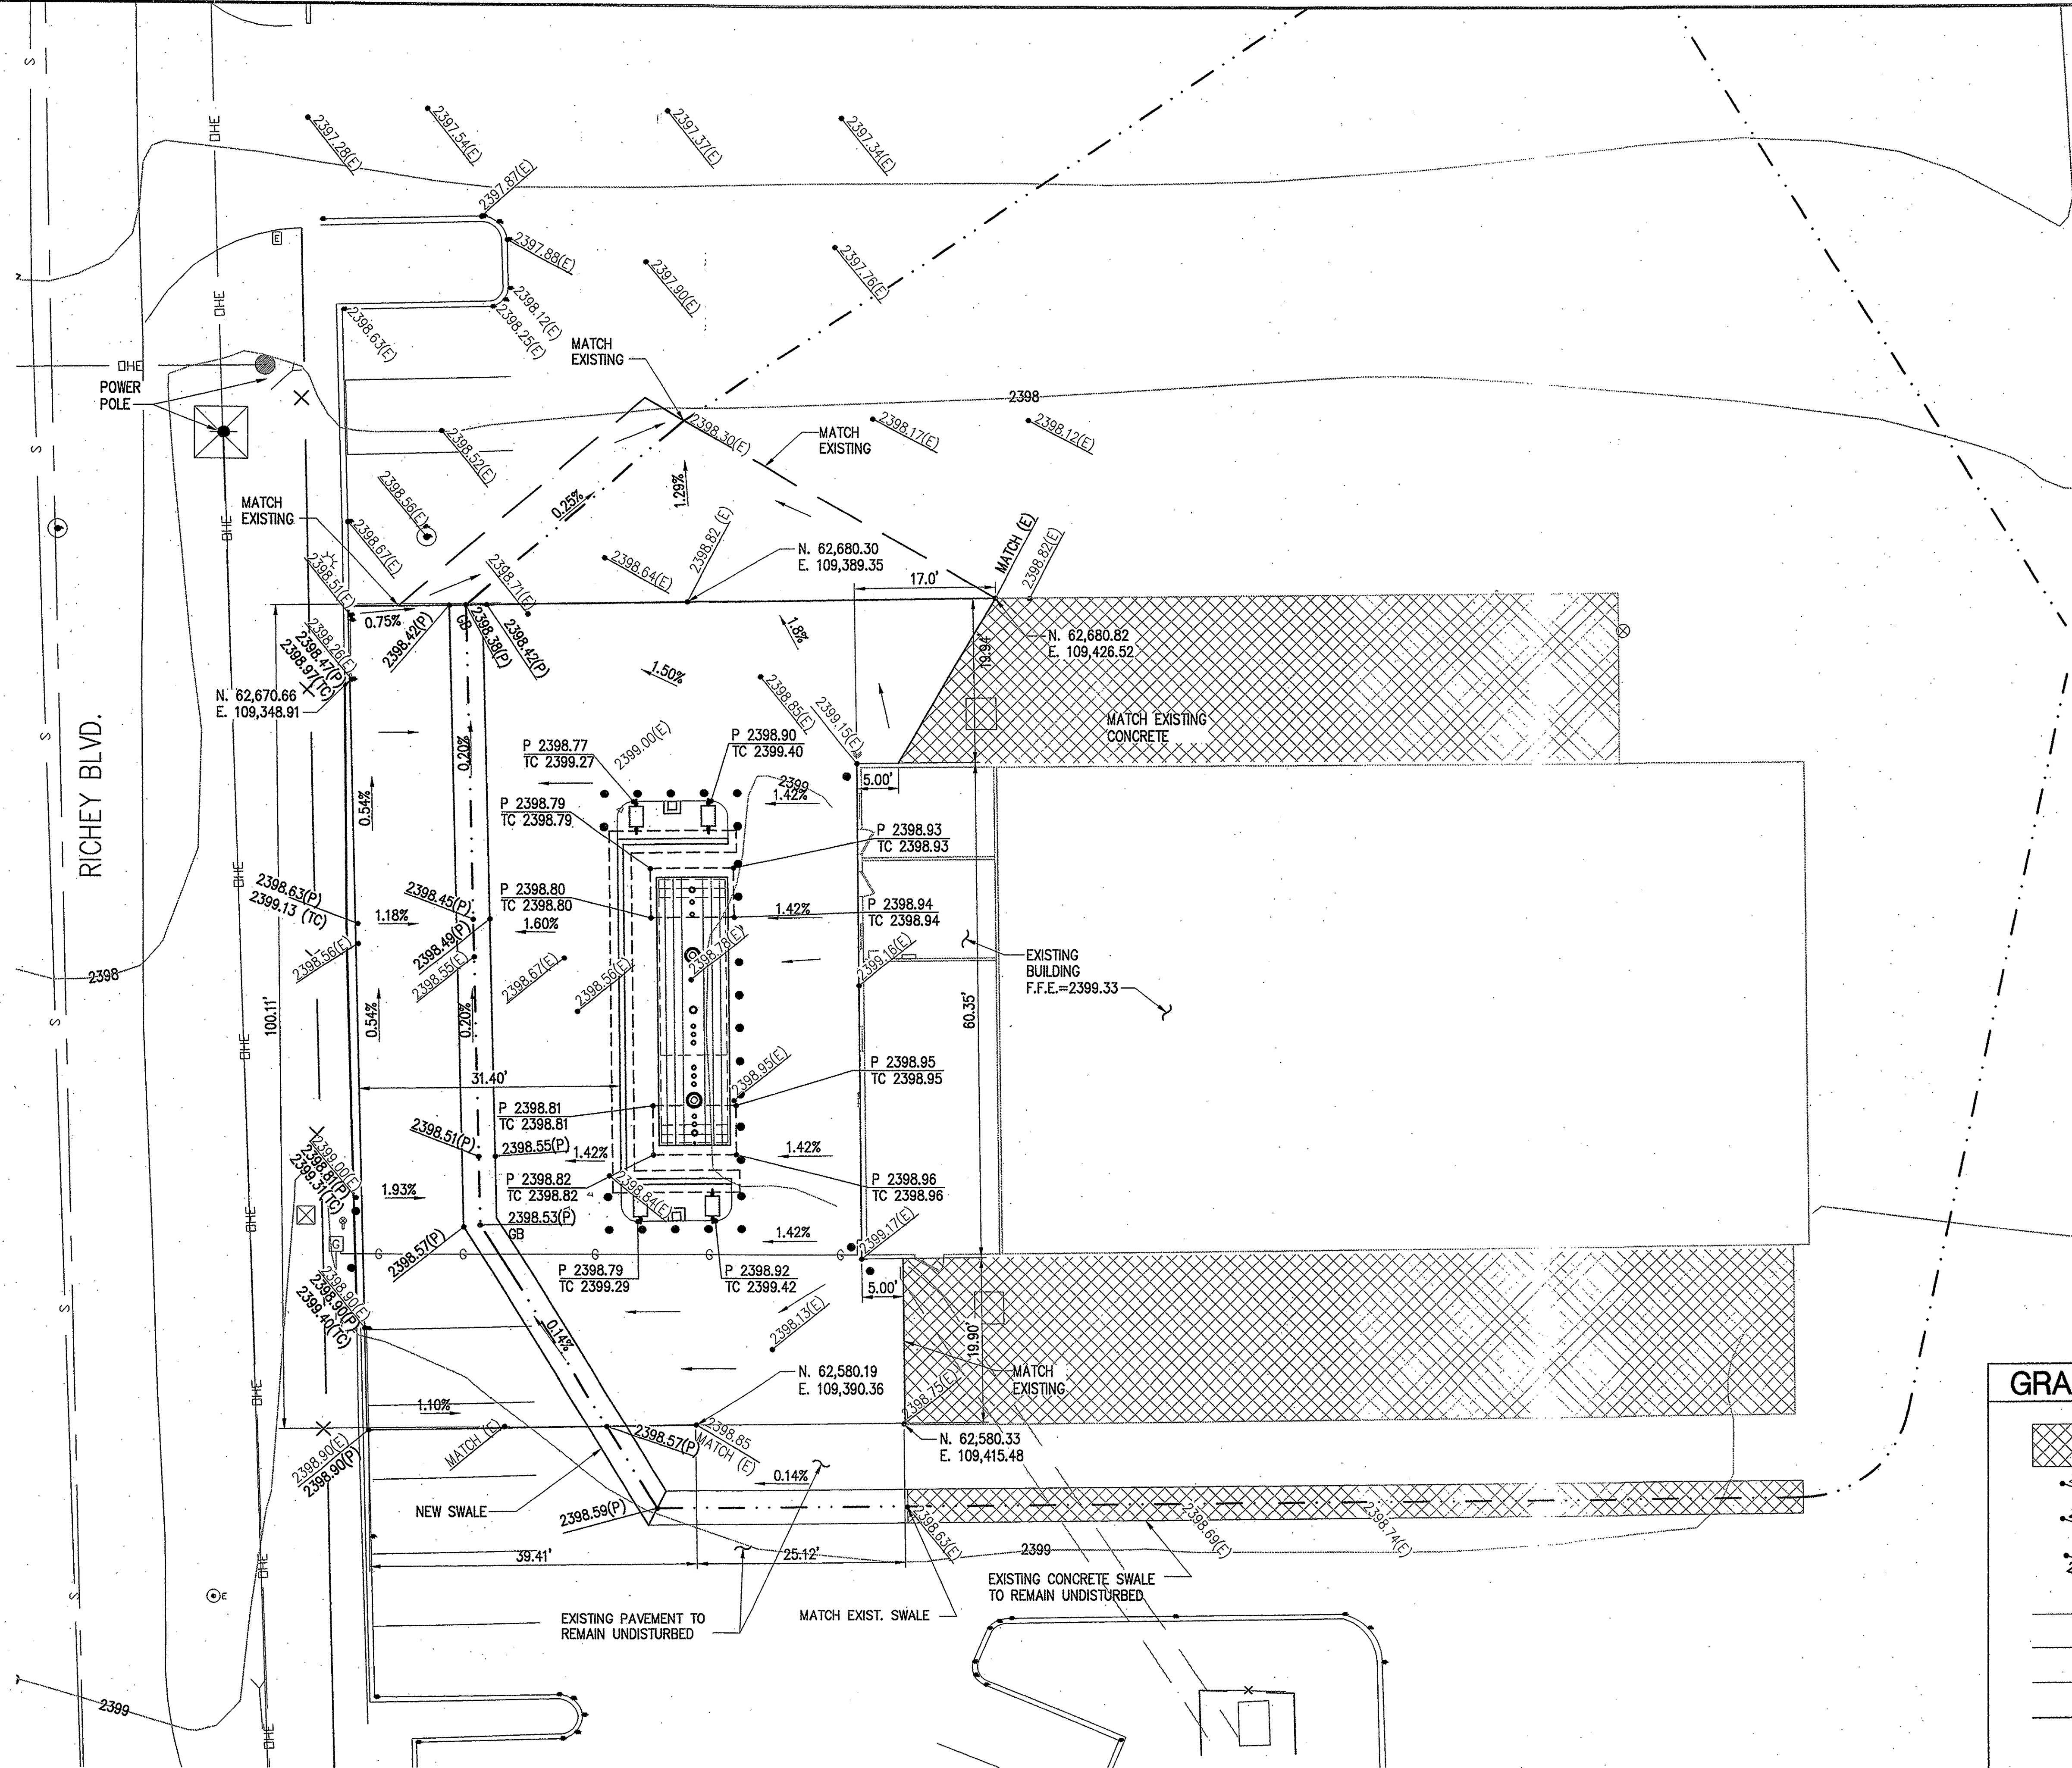

CIVIL SITE GRADING PLAN

SCALE: 1" = 10'



File: P:\2010\100100\Civil\100100.dwg LAST UPDATE: 1/4/2011 11:33 AM BY: RUI/TKA